



SINGLE LINE DIAGRAM

SAMPLE DRAWING ONLY
NOT FOR CONSTRUCTION

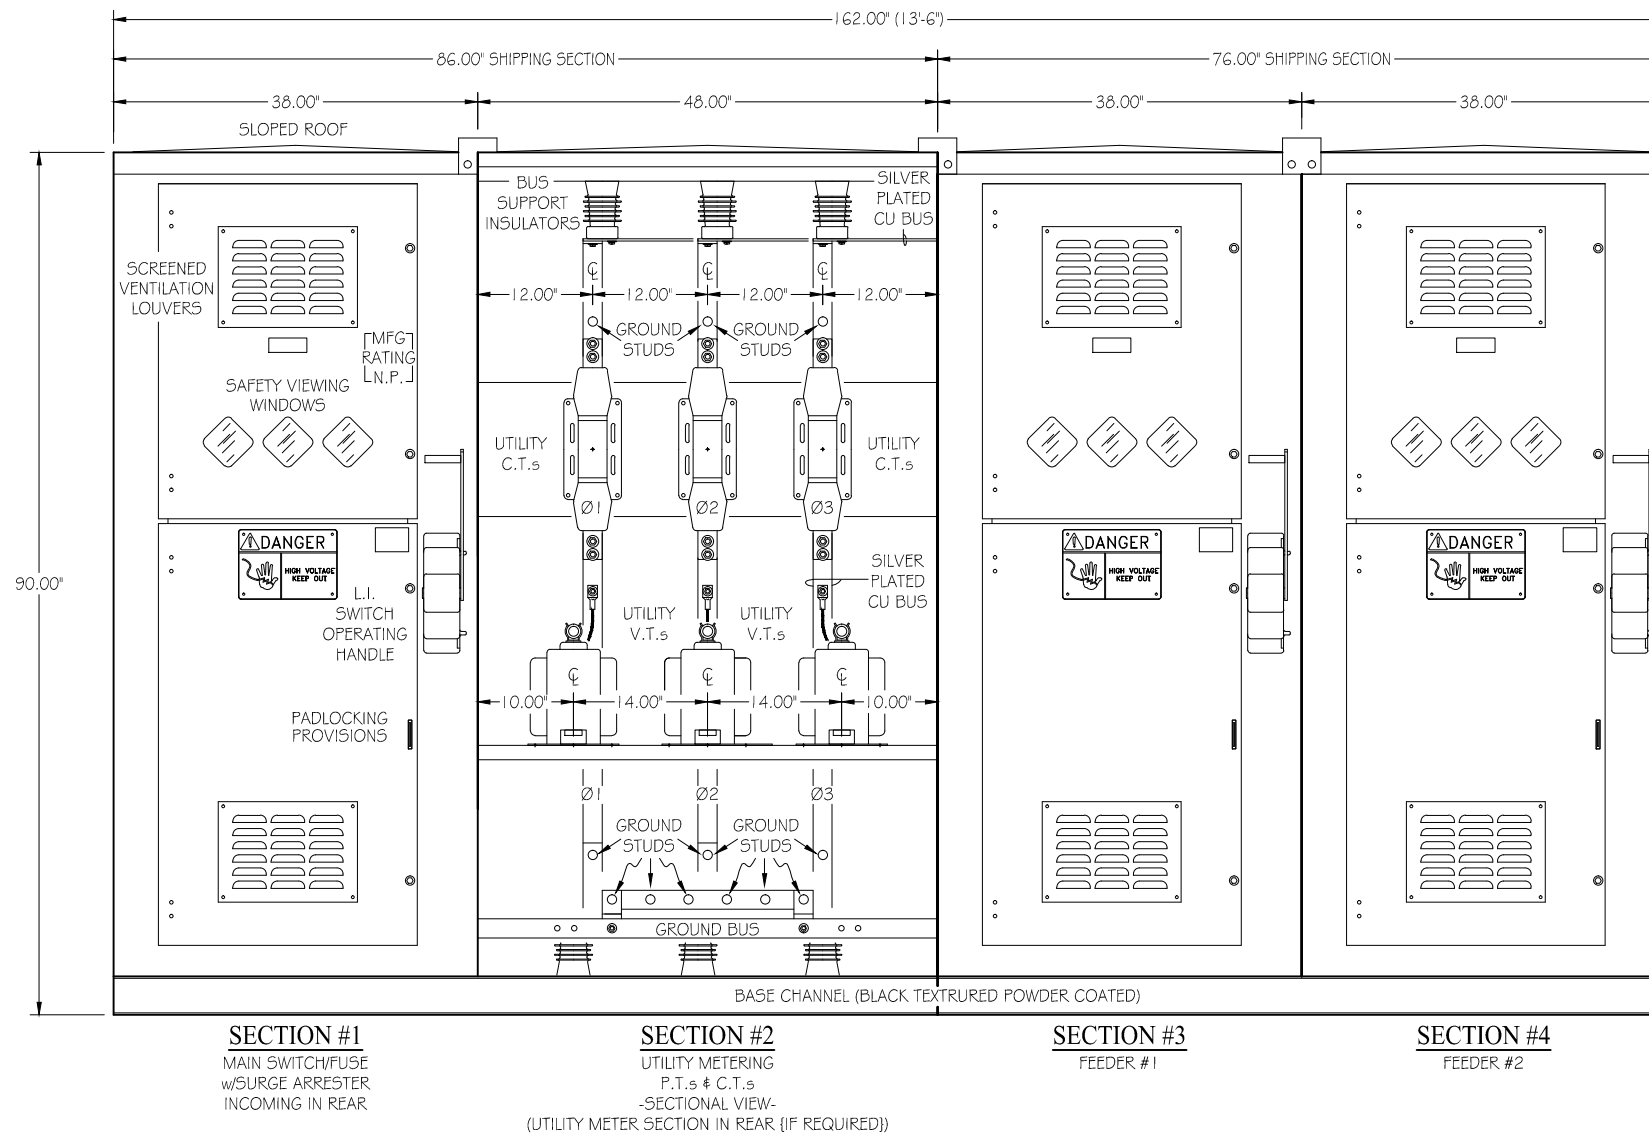

FRONT ELEVATION

NO.	DATE	REVISION	BY:
PROPRIETARY NOTE: THIS DRAWING CONTAINS PROPRIETARY INFORMATION OF JAGG ELECTRICAL & CONTROL. THIS PROPRIETARY INFORMATION MAY NOT BE USED, REPRODUCED, OR DISCLOSED TO ANY OTHER PARTIES FOR ANY OTHER PURPOSE WITHOUT THE EXPRESSED WRITTEN PERMISSION OF JAGG ELECTRICAL & CONTROL.			
CUSTOMER: SAMPLE			
P.O.#: ***			
PROJECT: SAMPLE			
METAL-ENCLOSED UTILITY SERVICE ENTRANCE SWITCHGEAR ASSEMBLY 15KV, 600 AMP, 95KV BIL -OUTDOOR-			
			
4870 PACKARD ROAD, NIAGARA FALLS, NY, 14304 ♦ PHONE: (716) 278-1440 ♦ WEB: JAGGEC.COM ♦			
CHECKED BY: GMG			
DRAWN BY: J. AGNELLO			
DATE: 6/21/11		SHEET: 1 OF 1	
DRAWING #: SAMPLE			